


WALL CONSTRUCTION
 4" BRICK VENEER
 1 1/2" AIR SPACE
 BUILDING PAPER
 1/2" PLYWOOD SHEATHING
 2X6 FRAMED WALL @ 16" O.C.
 W/ BATT INSULATION
 VAPOUR BARRIER
 1/2" GYPSUM BOARD

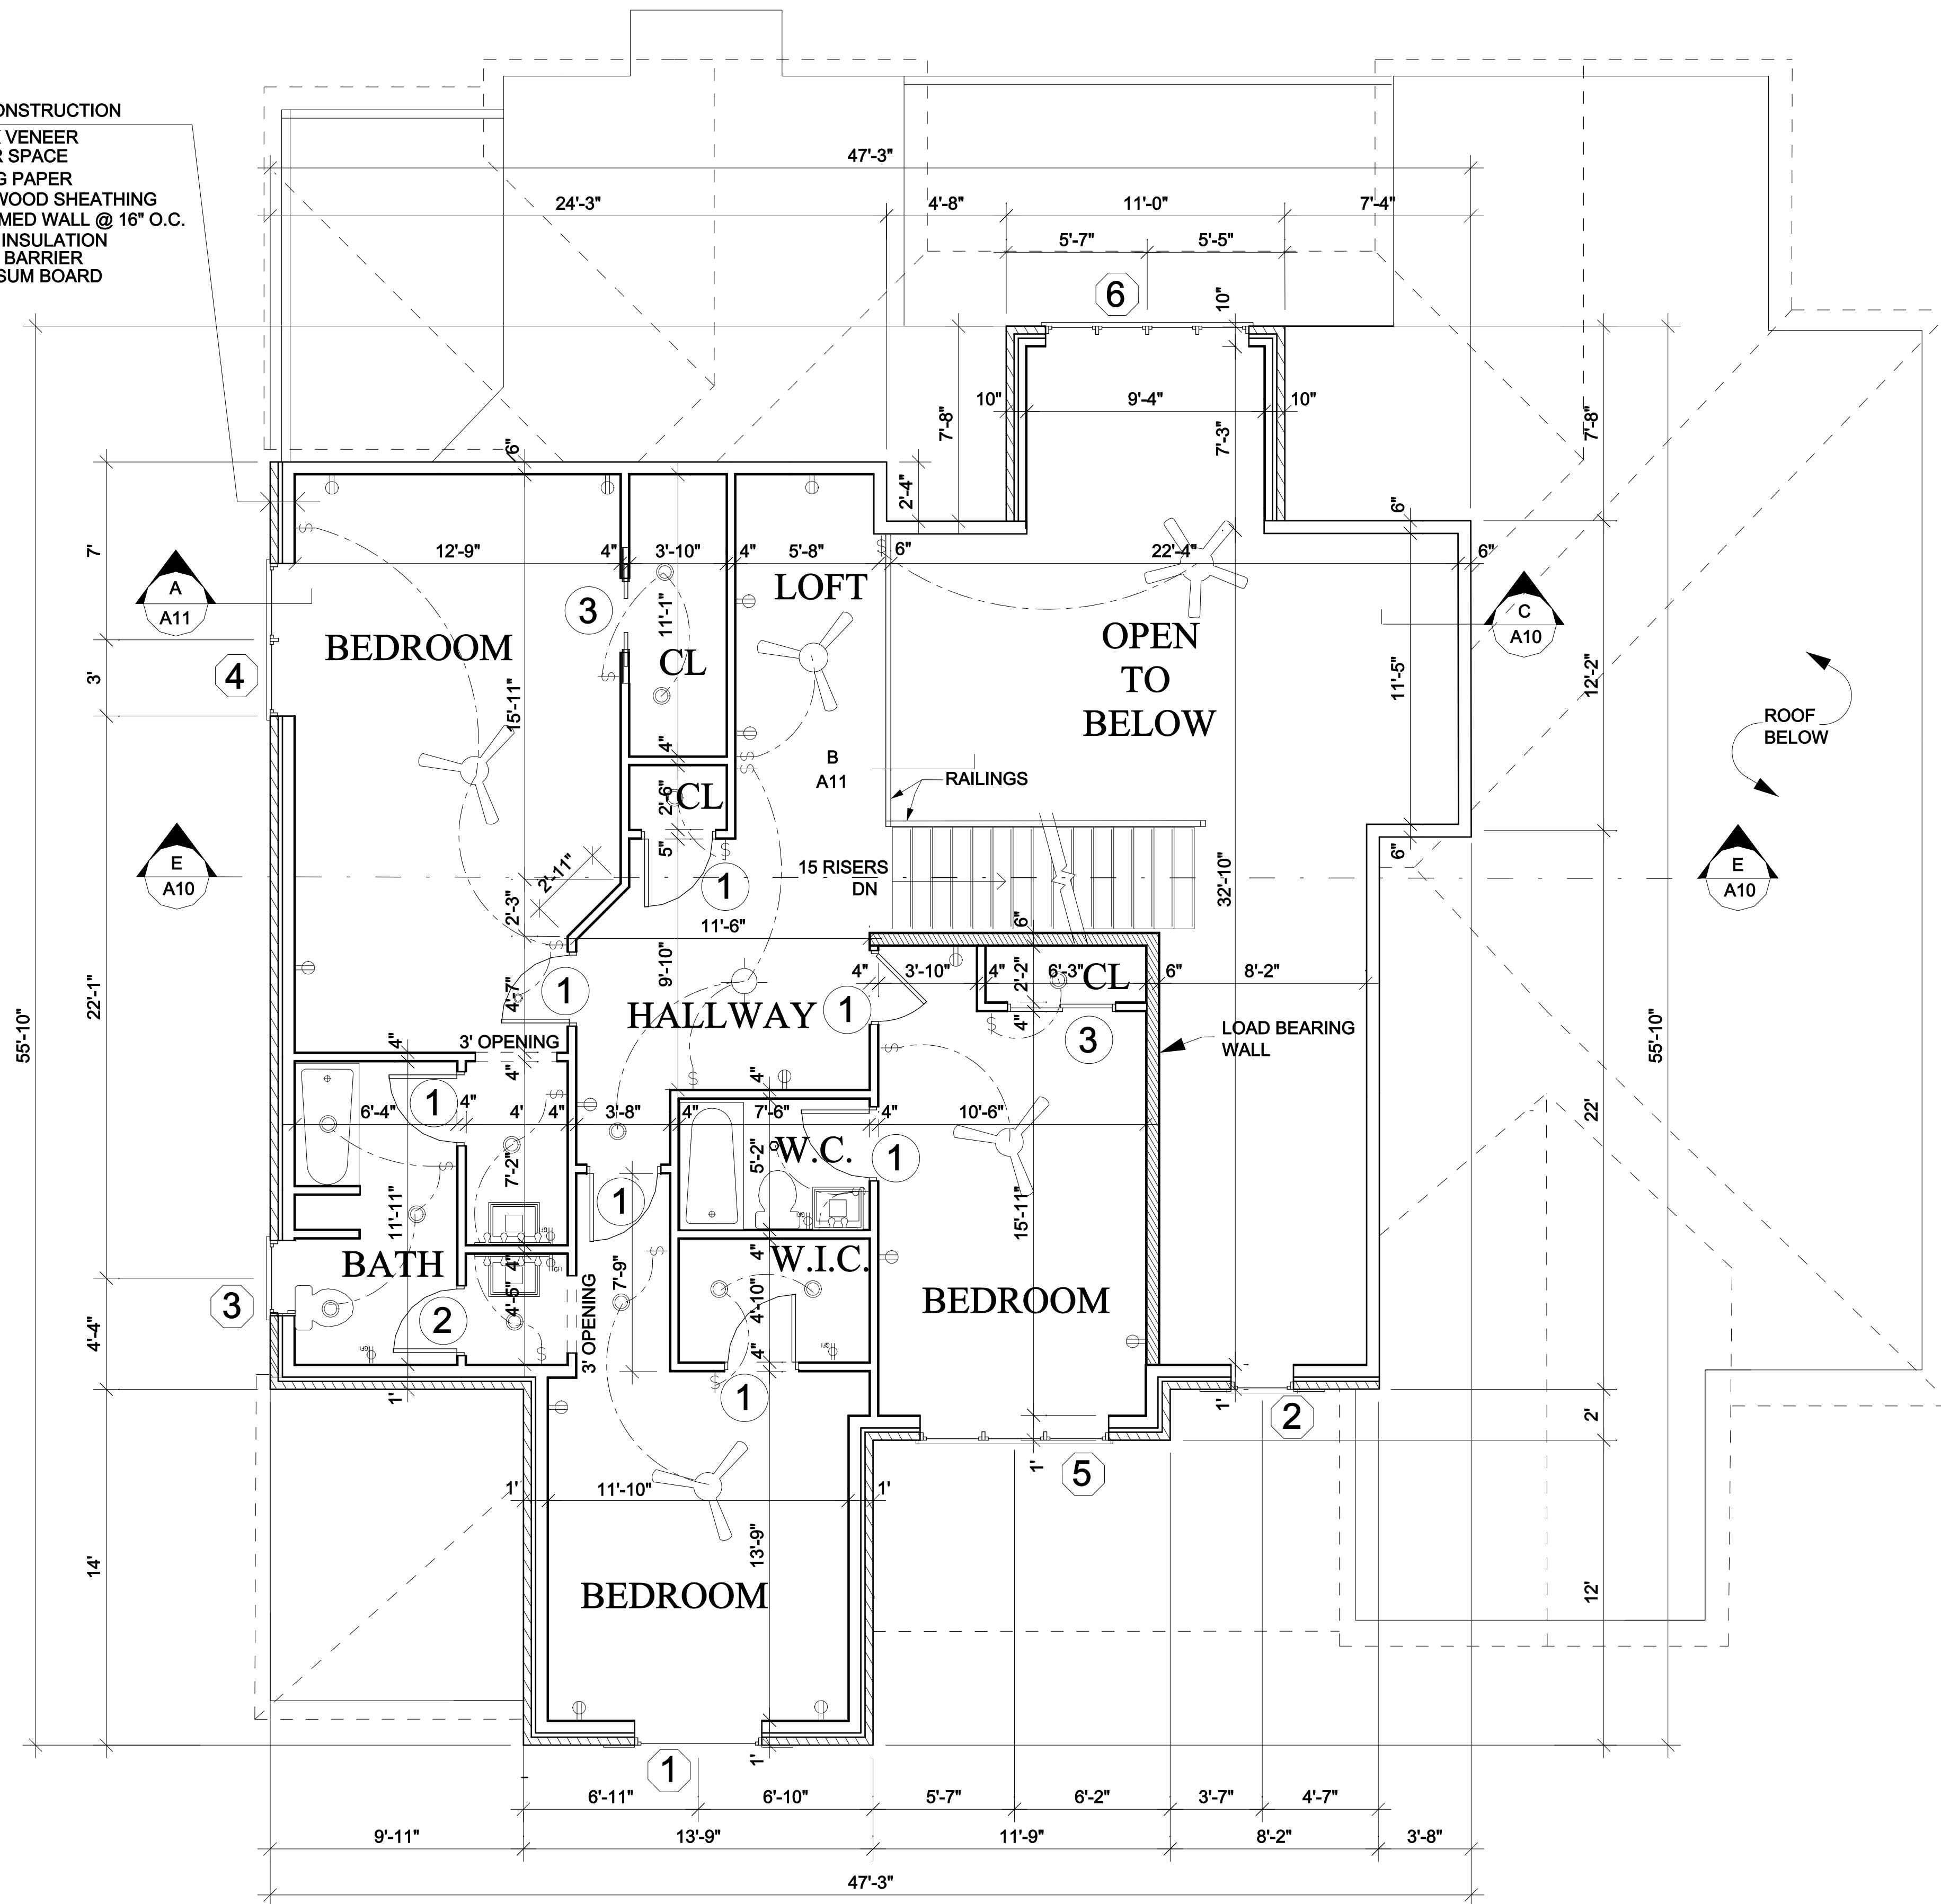

X Window Schedule

Mark	Size	Description	Count
1	5' X 6'	5'-0" X 6'-0" Double Hung Window	1
2	2'-6" X 4'-1"	2'-6" X 4'-1" Double Hung Window	1
3	3'-0" X 3'-6"	3' X 3'-6" Double Hung Window	1
4	6' X 4'	6' X 4'-0" Double Hung Window	1
5	7'-6" X 5'	7'-6" X 5'-0" Double Hung Window	1
6	8' X 5'	8'-0" X 5'-0" Double Hung Window	1

X Door Schedule

Mark	Size	Description	Count
1	2'-8" X 6'-8"	32" Hinged Door	7
2	2'-6" X 6'-8"	30" Hinged Door	1
3	2'-8" X 6'-8"	32" Pocket Door	2



ELECTRICAL LEGEND

	CEILING LIGHT
	POT LIGHT
	120V OUTLET
	SINGLE SWITCH
	DOUBLE SWITCH

SECOND FLOOR PLAN

SCALE: 1/4" = 1'-0"

General Notes

No.	Revision/Issue	Date

Orientation: _____ Stamp: _____

ALL DRAWINGS ARE THE PROPERTY OF THE DESIGNER AND THEY ARE NOT TO BE REPRODUCED IN WHOLE OR IN PART WITHOUT THE WRITTEN CONSENT OF THE DESIGNER.
 CONTRACTOR TO CHECK AND VERIFY ALL DIMENSIONS BEFORE COMMENCING WORK AND TO REPORT ANY DISCREPANCIES TO THE DESIGNER.

Project Name and Address:
McFarlin House

Client:
Steve Wise

Drawing:
Second Floor Plan
 Scale: 1/4" = 1' - 0" Date: Sept. 2007

Drawn By: S.J.W. Sheet:
 Checked By: **A-4**
 Approved By: _____